


PLAN SHOWING THE PROPOSED CONSTRUCTION OF R.C.C ROOF BUILDING FOR "ST JOSEPH'S INTERNATIONAL SCHOOL" RUN BY VINNARASI EDUCATIONAL AND SOCIAL SERVICE TRUST IN S.NO.56/2B2,56/3B2,56/3F5B,56/75,AT SETHARAPALLI VILLAGE, ANCHOOR PANCHAYAT, BARUGUR UNION & TALUK KRISHNAGIR DISTRICT, SCALE - 1:100

SHEET NO - 3/3

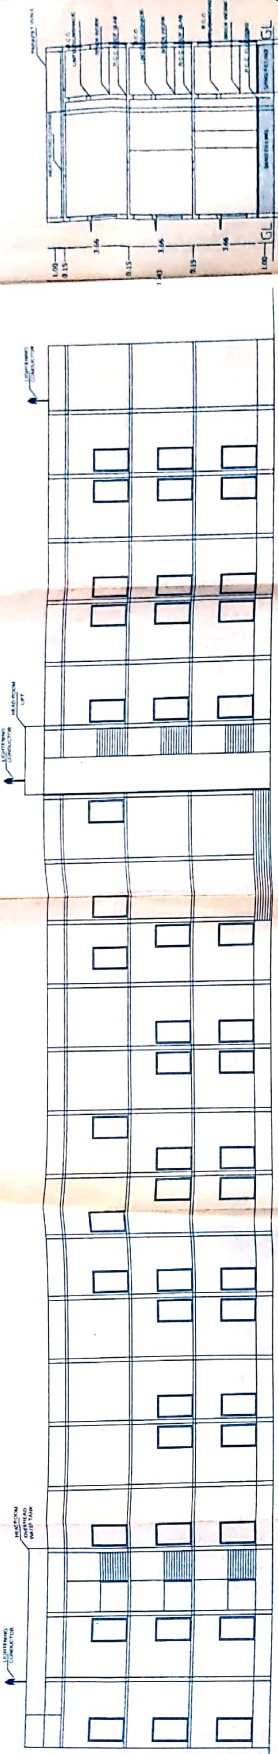


JOINTERY DETAILS  
 D-DOOR 091X213  
 JI-JOOLY WORK 2.44X0.91  
 AREA OPEN TERRACED - 55.87  
 OFFICE USE



APPLICANT  
 ENGINEER

APPROVAL THIS OFFICE  
 R.C.C. No. 117/2017  
 Date: 11/01/2017  
 SPECTRUM ENGINEERING  
 11/01/17

Signature  
 H.S. CONSTRUCTION  
 PANCHAYAT, BARUGUR

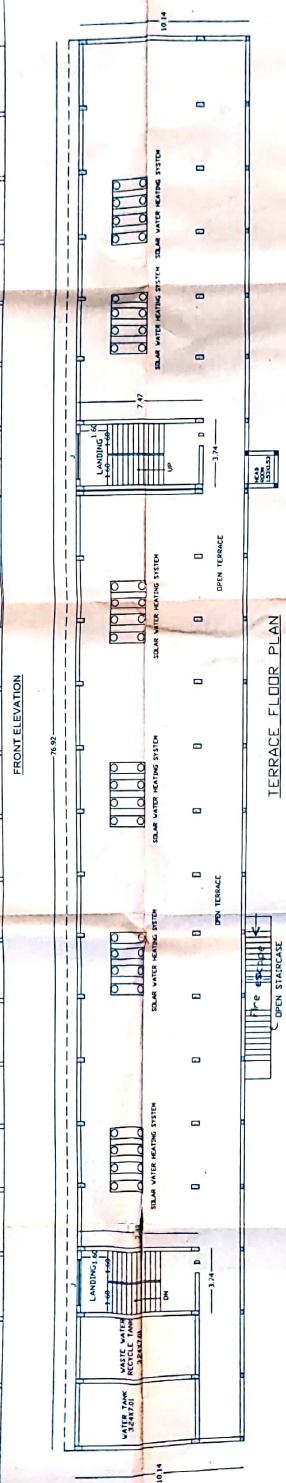

TERRACE FLOOR PLAN

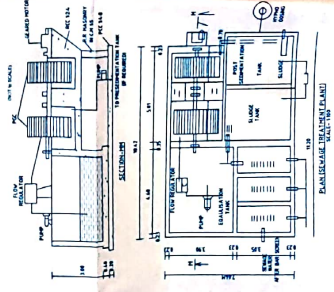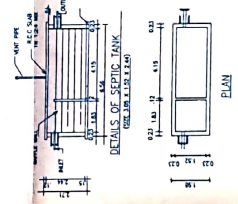

- 11.201 DETAILS OF RAIN WATER HARVESTING STRUCTURES
- INLET PIPE Ø 150
  - FINE SAND
  - COARSE SAND
  - 20MM STONE AGGREGATE
  - 40MM STONE AGGREGATE
  - CASING PIPE

Handwritten notes and signatures in a box, including the name 'SPECTRUM ENGINEERING'.

